


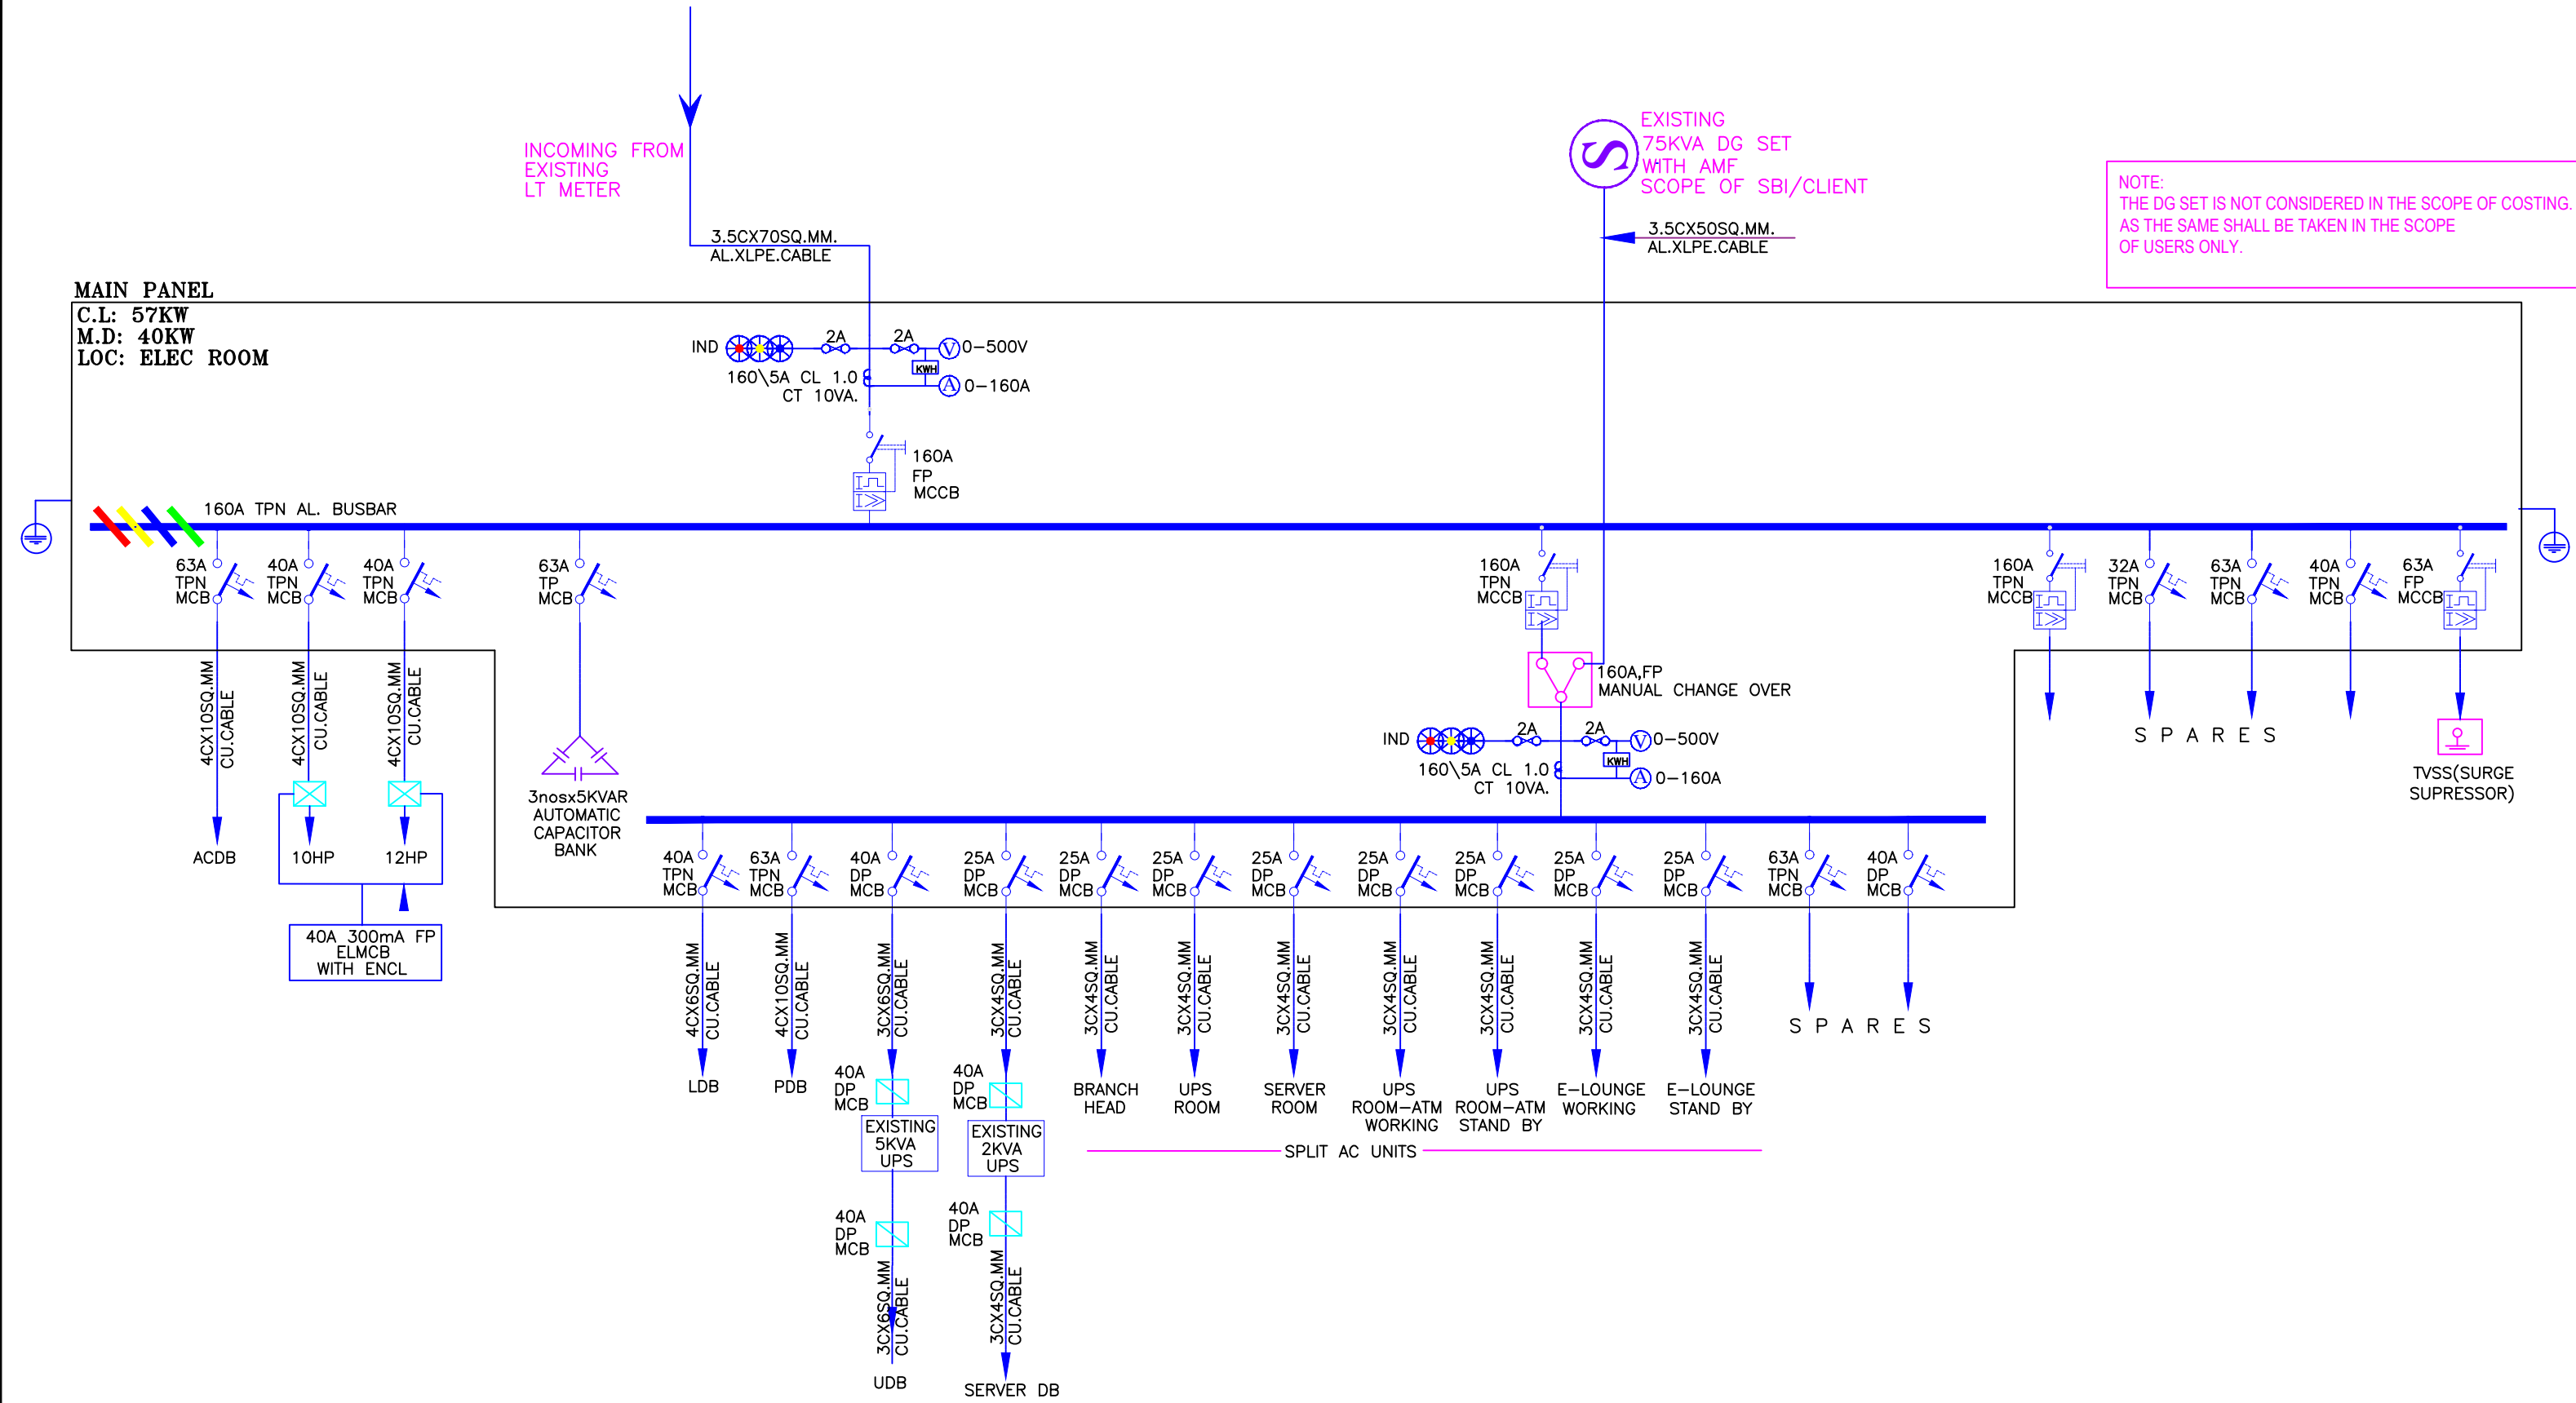

			Client:		Project Title:		Drawing Title:			
			SBI		SBI - ICRISAT @ HYDERABAD		SINGLE LINE DIAGRAM			
			Architect:		MEP CONSULTANTS:		DATE:	09/01/2019	PROJECT NO:	SBI-IC-01
			mape connaisseurs, 3-4-485&485/1 1st FLOOR D1 AGARWAL APPARTMENTS, NEAR BANK OF BARODA.HYD-27 TEL. NO.: 27566409,27566691 E-MAIL : mapehyd1@gmail.com		SMEP CONSULTANTS Masab Tank, Hyderabad - 500057 www.smeconsultants.com		DRAWN:	NAVANEETHA	SCALE:	NTS
							CHECKED:	REDDY	SHEET SIZE:	A3
							APPROVED:	REDDY	BLOCK NO:	A
							DRAWING NO:	SMEP/SBI-IC-01/ELE/SLD/01		
										ISSUED FOR
										INFORMATION
										NORTH
										REVISION:
										R1

REV.No.	Description	Date
A		