


GROUND FLOOR PLAN

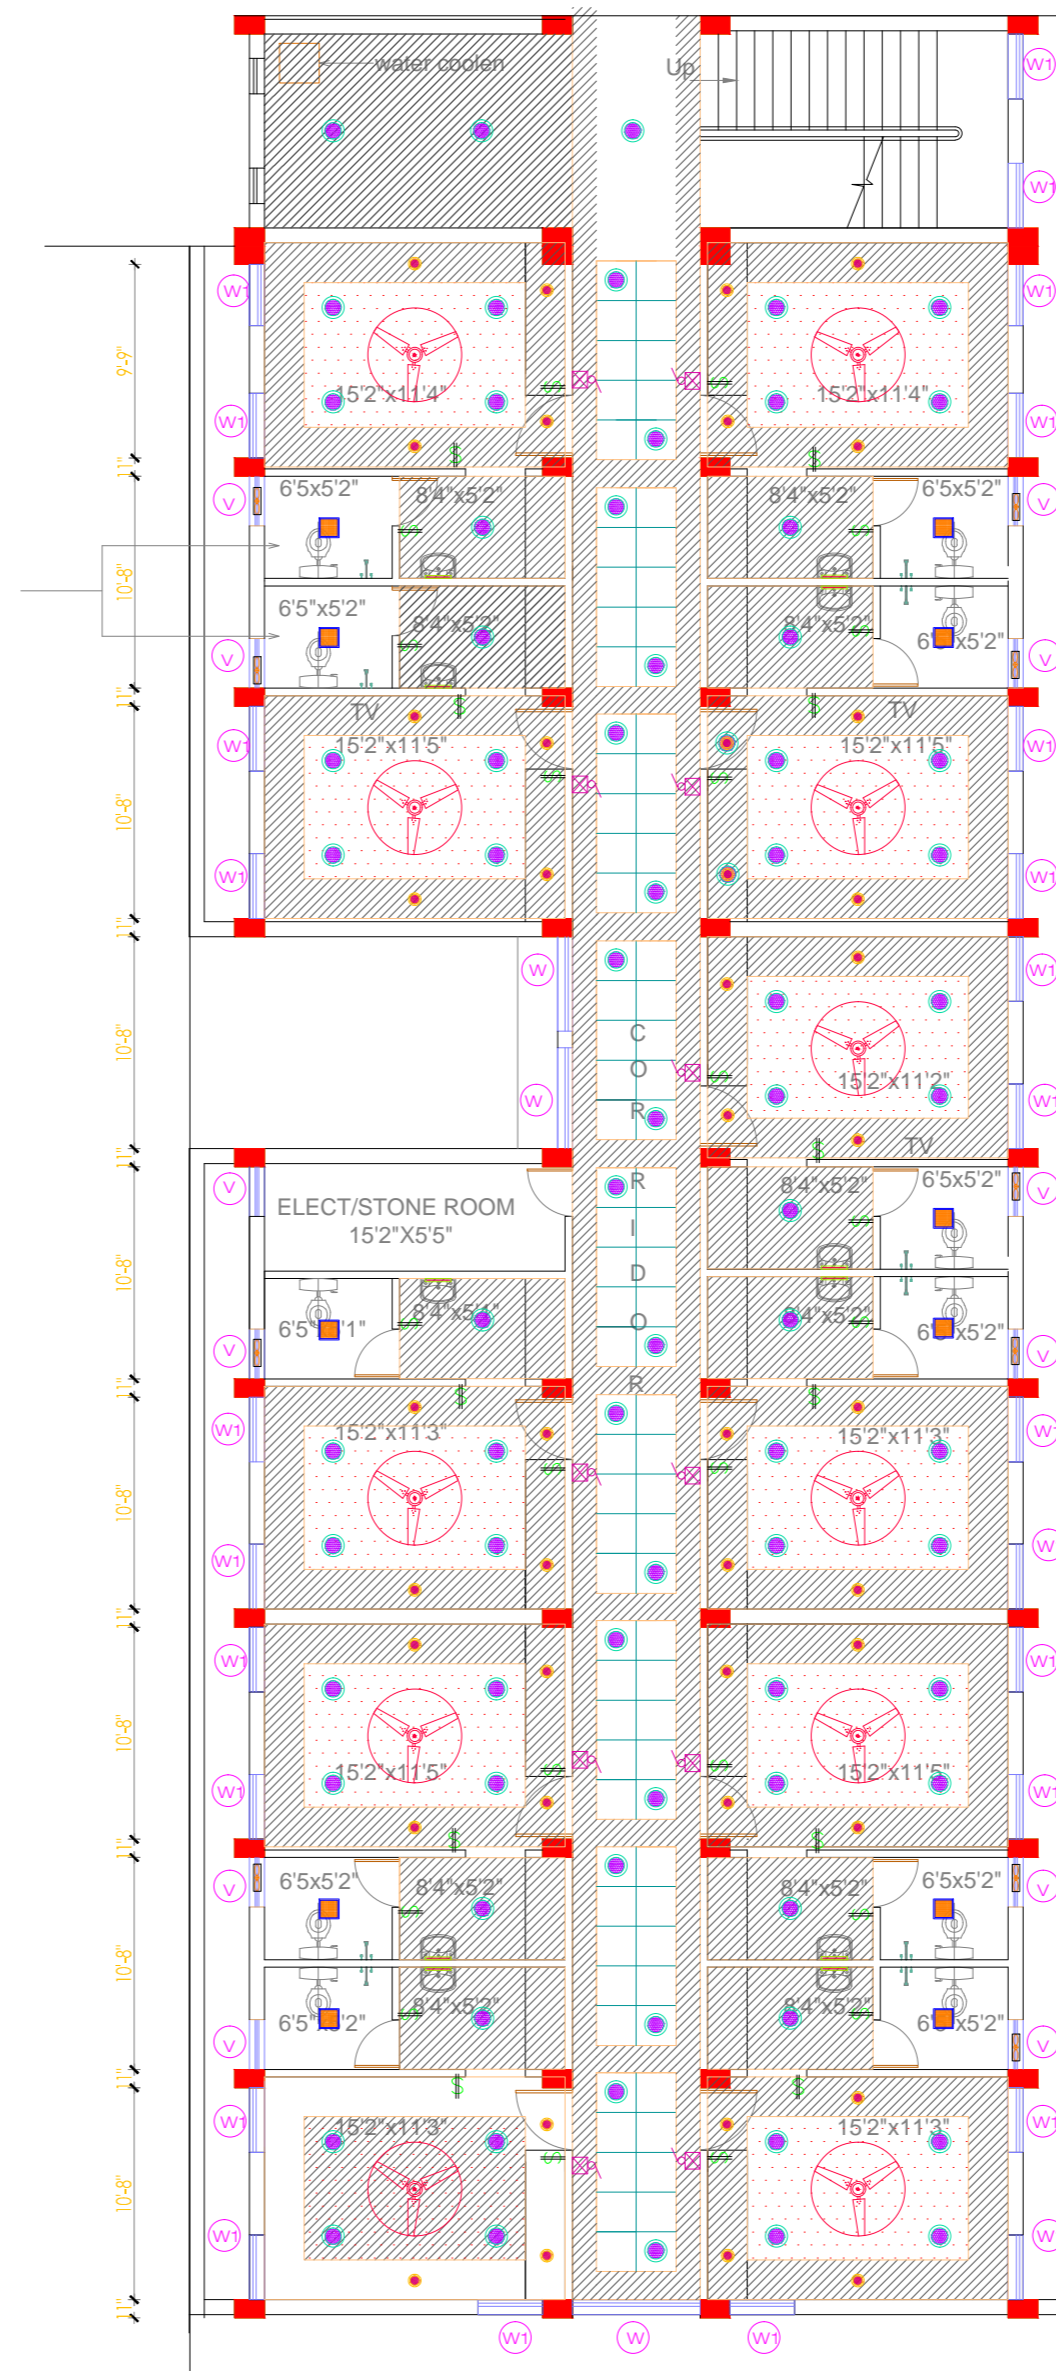

FIRST FLOOR PLAN

Legend:

	DESCRIPTION
	7W LED RECESSED MOUNT DOWN LIGHT FITTING
	SWITCH BOX
	18W LED RECESSED MOUNT DOWN LIGHT FITTING
	12W LED SURFACE MOUNT DOWN LIGHT FITTING
	10W LED MIRROR LIGHT FITTING
	EXHAUST FAN
	16/20A MAIN CONTROL SWITCH
	20W LED BATTEN TYPE FITTING
	CEILING FAN(BLDC)

1. This drawing is sole property of 'Pithavadian and Partners' and must not be reproduced or altered either in full or in part by anyone without consent from us or be passed to any individual or company not authorised by us.
2. Any discrepancy in the drawing should be brought to the immediate attention of the Architect
3. All dimensions in millimeters and levels in meters.
4. Dimensions to be followed as indicated and not to be scaled

NAME OF THE PROJECT:
**PROPOSED INTERIOR RENOVATION FOR
 SBILD MACHILIPATNAM, AMARAVATHI.**

CLIENT:
STATE BANK OF INDIA

DRAWING TITLE:
LIGHTING LAYOUT

CONSULTANT:
PITHAVADIAN AND PARTNERS

SCALE: 1:100@A4	DESIGN BY: AKV	DRAWN BY: ALAN	CHECKED BY: AKV
DATE: 18-08-2022	SIGN:	SIGN:	SIGN:

ISSUED FOR: SCHEME TENDER INFORMATION APPROVAL CONSTRUCTION

ARCHITECTURE * INTERIORS * PLANNING * ENGINEERING * MANAGEMENT

PITHAVADIAN AND PARTNERS
 Chennai Bengaluru Kochi Hyderabad.
 NO.10, Nawab Garden, Murugappa Street,
 Kotturpuram, Chennai - 600 085.
 Ph: +91 (0) 44 2447 0033 / 44 / 66.
 Fax: +91 (0) 44 2447 0888 / 42132797.
 email: mail@paparchitect.com
 website: www.paparchitect.com



JOB NO: - DWG NO: 1 REV NO: