




GENERAL NOTES:
 1. THIS DRAWING IS A PROPERTY OF DESIGN TECHNIQS AND IS NOT TO BE USED OR REPRODUCED WITHOUT PERMISSION.
 2. ALL DIMENSIONS ARE IN MM UNLESS SPECIFIED OTHERWISE.
 3. ONLY WRITTEN DIMENSIONS ARE TO BE FOLLOWED, NO DIMENSIONS ARE TO BE PHYSICALLY MEASURED FROM THE DRAWING. DRAWINGS ARE NOT TO BE SCALED.
 4. CONTRACTORS / VENDORS MUST VERIFY DIMENSIONS ON THE PROJECT AND REPORT DISCREPANCIES IF ANY TO DESIGN TECHNIQS.
 5. DRAWINGS SHALL BE READ IN CONJUNCTION WITH SERVICES / STRUCTURE RELATED DRAWINGS.

LEGEND:

SYMBOL	DESCRIPTION
	PHOTOLUMINESCENT SAFETY SIGNAGES "ARROW + SYMBOL" (DOUBLE SIDE-HANGING TYPE) - SIZE 150 X 400MM
	PHOTOLUMINESCENT SAFETY SIGNAGES "ARROW + SYMBOL" (DOUBLE SIDE-HANGING TYPE) - SIZE 150 X 400MM
	PHOTOLUMINESCENT SAFETY SIGNAGES "FIRE EXIT" - WITH SYMBOL, SIZE 150 X 400MM
	PHOTOLUMINESCENT SAFETY SIGNAGES "IN CASE OF FIRE, DO NOT USE LIFT, USE STAIR" - WITH SYMBOL, SIZE 250 X 300MM
	PHOTOLUMINESCENT SAFETY SIGNAGES "FIRE HYDRANT & HOSE REEL" - WITH SYMBOL, SIZE 150 X 200MM

LEGEND:

SYMBOLS	DESCRIPTION
	ABC STORED PRESSURE TYPE FIRE EXTINGUISHER-4KG WITH SIGNAGES
	MECHANICAL FOAM 9LTR WITH SIGNAGES
	CO2 FIRE EXTINGUISHER 4.5KG WITH SIGNAGES

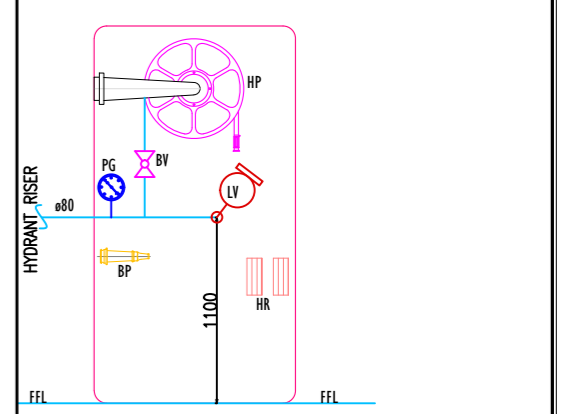

- FIRE HOSE CABINET CONSIST OF
- 1 NOS OF 63# SINGLE HEADED LANDING VALVE
 - 2 LENGTHS OF 63# RRL HOSE 15M LONG
 - 1 No of HOSE REEL DRUM WITH ø20x36M LONG
 - 1 NO OF BRANCH PIPE
 - 1 NO OF ø20 BALL VALVE
 - 1 NO OF PRESSURE GAUGE WITH 1/2" BALL VALVE TYPICAL HYDRANT SHAFT ACCESSORIES

REVISIONS:

REV. NO	DESCRIPTION	DATE	REMARK
R0	ISSUED FOR APPROVAL	05.07.2022	

CLIENT:

ARCHITECT:
SHETGIRI & ASSOCIATES
 ARCHITECTS, ENGINEERS, INTERIOR DESIGNERS,
 PROJECT MANAGEMENT CONSULTANTS, VALUERS
 1st Floor, Block no 1, Safalya Bldg, S.K.Bole Road DADAR(W), MUMBAI-400 028
 PAX: 91-22-2431 6702; TEL: 91-22-2422 2600/2422 4014 CELL: 919821138367
 E-MAIL: shetgiriassociates@pbhoos.co.in / shetgiriassociates@gmail.com

MEP CONSULTANTS:
DESIGN TECHNIQS
 101, 102, 103, 999, 1000.


PROJECT: SBI STAFF QUARTER

DRAWING NAME: GROUND FLOOR FIRE FIGHTING LAYOUT

DRAWING NO: DT-SBI/FF/001

SCALE:	DATE:	REVISION:	SHEET SIZE:
NTS	05.07.2022	R0	A0

DRAWN BY:	CHECKED BY:	APPROVED BY:	NORTH
TAMIL	PJ	AS	

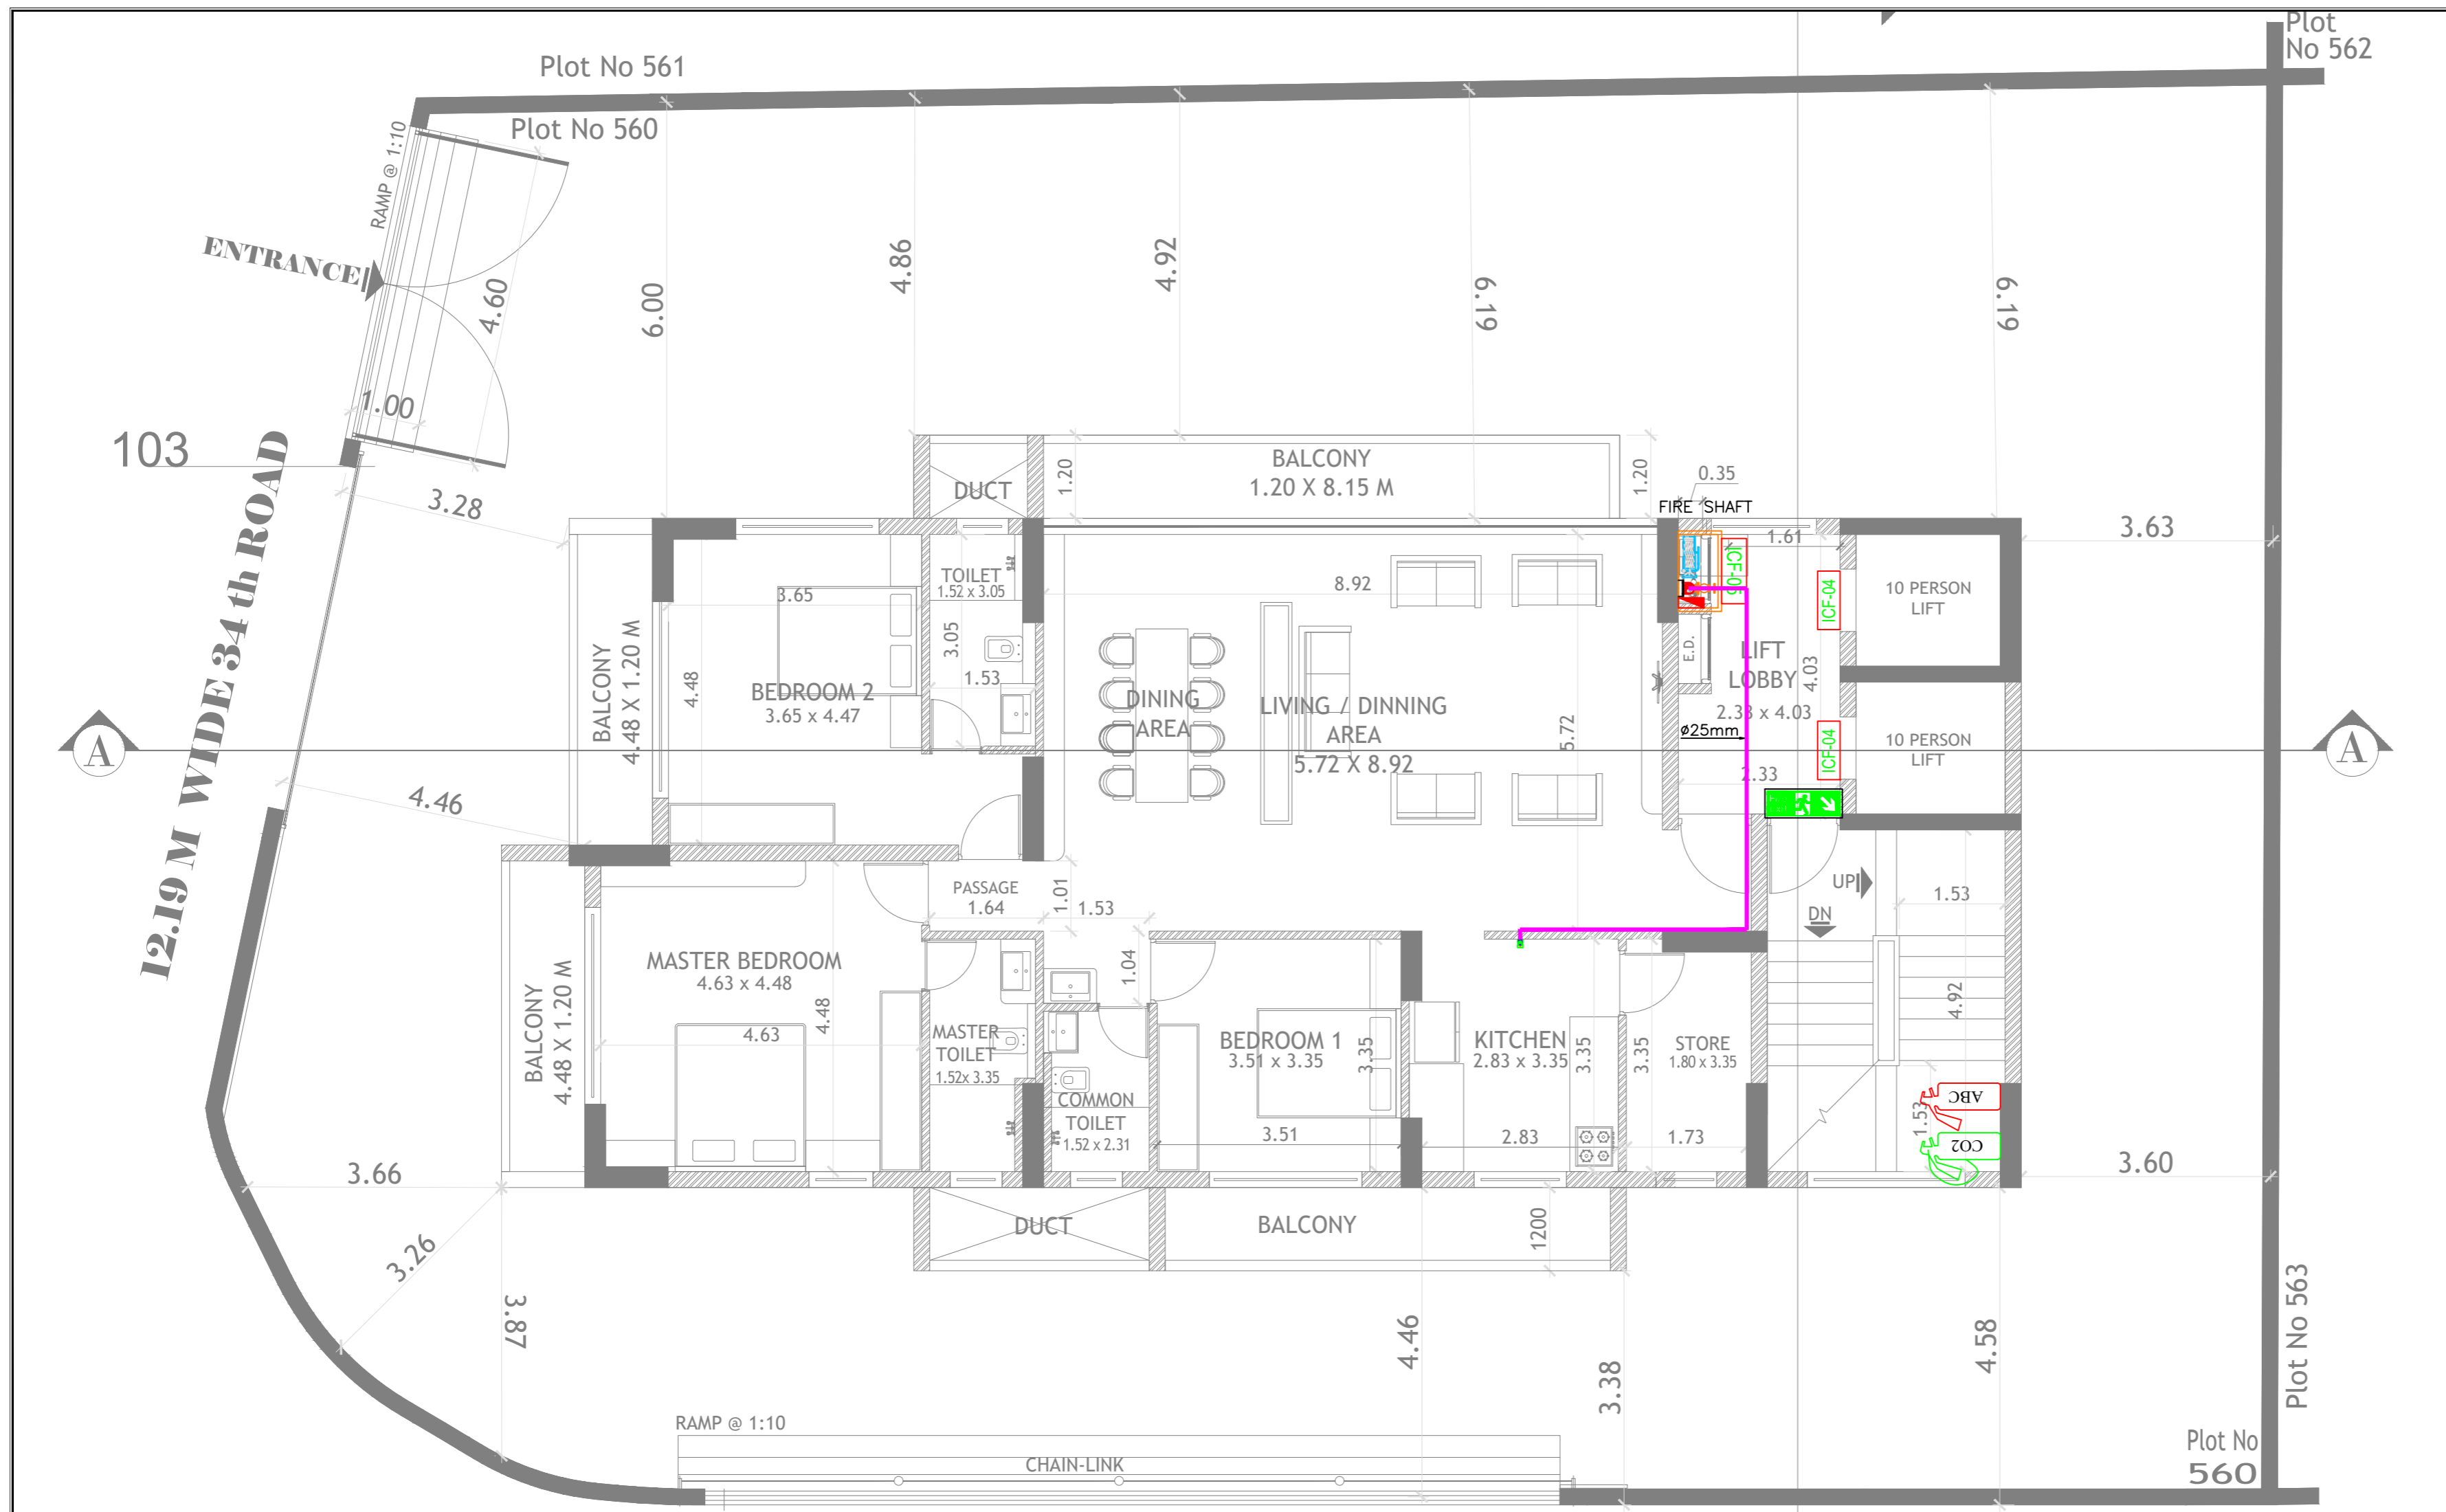


GENERAL NOTES:
 1. THIS DRAWING IS A PROPERTY OF DESIGN TECHNIQS AND IS NOT TO BE USED OR REPRODUCED WITHOUT PERMISSION.
 2. ALL DIMENSIONS ARE IN MM UNLESS SPECIFIED OTHERWISE.
 3. ONLY WRITTEN DIMENSIONS ARE TO BE FOLLOWED, NO DIMENSIONS ARE TO BE PHYSICALLY MEASURED FROM THE DRAWING. DRAWINGS ARE NOT TO BE SCALED.
 4. CONTRACTORS / VENDORS MUST VERIFY DIMENSIONS ON THE PROJECT AND REPORT DISCREPANCIES IF ANY TO DESIGN TECHNIQS.
 5. DRAWINGS SHALL BE READ IN CONJUNCTION WITH SERVICES / STRUCTURE RELATED DRAWINGS.

LEGEND:

SYMBOL	DESCRIPTION
	PHOTOLUMINESCENT SAFETY SIGNAGES "ARROW + SYMBOL" (DOUBLE SIDE-HANGING TYPE) - SIZE 150 X 400MM
	PHOTOLUMINESCENT SAFETY SIGNAGES "ARROW + SYMBOL" (DOUBLE SIDE-HANGING TYPE) - SIZE 150 X 400MM
	PHOTOLUMINESCENT SAFETY SIGNAGES "FIRE EXIT" - WITH SYMBOL, SIZE 150 X 400MM
	PHOTOLUMINESCENT SAFETY SIGNAGES "IN CASE OF FIRE, DO NOT USE LIFT, USE STAIR" - WITH SYMBOL, SIZE 250 X 300MM
	PHOTOLUMINESCENT SAFETY SIGNAGES "FIRE HYDRANT & HOSE REEL" - WITH SYMBOL, SIZE 150 X 200MM

LEGEND:

SYMBOLS	DESCRIPTION
	ABC STORED PRESSURE TYPE FIRE EXTINGUISHER-4KG WITH SIGNAGES
	MECHANICAL FOAM 9LTR WITH SIGNAGES
	CO2 FIRE EXTINGUISHER 4.5KG WITH SIGNAGES

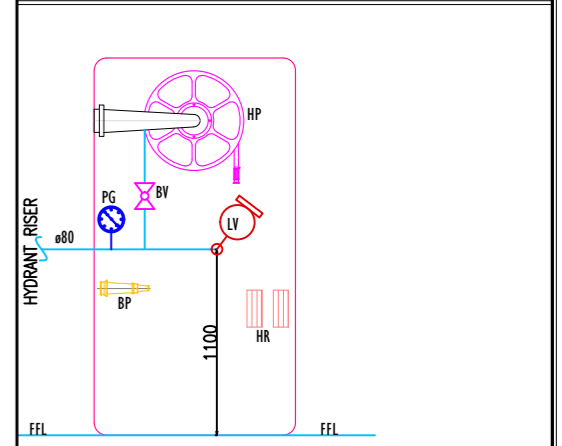

FIRE HOSE CABINET CONSIST OF
 1. 1 NOS OF 63Ø SINGLE HEADED LANDING VALVE
 2. 2 LENGTHS OF 63Ø RRL HOSE 15M LONG
 3. 1 No of HOSE REEL DRUM WITH Ø20x36M LONG
 4. 1 NO OF BRANCH PIPE
 5. 1 NO OF Ø20 BALL VALVE
 6. 1 NO OF PRESSURE GAUGE WITH 1/2" BALL VALVE TYPICAL HYDRANT SHAFT ACCESSORIES

REVISIONS:

REV. NO	DESCRIPTION	DATE	REMARK
R0	ISSUED FOR APPROVAL	05.07.2022	

CLIENT:

ARCHITECT:
SHETGIRI & ASSOCIATES
 ARCHITECTS, ENGINEERS, INTERIOR DESIGNERS,
 PROJECT MANAGEMENT CONSULTANTS, VALUERS
 143 Floor Block nos. 1, 2, 3, 99, 100
 1st Floor Block nos. 1, 2, 3, 99, 100
 E-MAIL: shetgiriassociates@shetgiri.com / shetgiriassociates@gmail.com

MEP CONSULTANTS:
DESIGN TECHNIQS
 101, 102, 103, 199, 200
 1st Floor Block nos. 1, 2, 3, 99, 100
 E-MAIL: designtechniqs@gmail.com
 Web: www.designtechniqs.com

PROJECT:
 SBI STAFF QUARTER


DRAWING NAME:
 1ST TO 8TH FLOOR FIRE FIGHTING LAYOUT

DRAWING NO:
 DT-SBI/1 TO 8TH FL/002

SCALE:	DATE:	REVISION:	SHEET SIZE:
NTS	05.07.2022	R0	A0

DRAWN BY:	CHECKED BY:	APPROVED BY:	NORTH
TAMIL	PJ	AS	




GENERAL NOTES:
 1. THIS DRAWING IS A PROPERTY OF DESIGN TECHNICS AND IS NOT TO BE USED OR REPRODUCED WITHOUT PERMISSION.
 2. ALL DIMENSIONS ARE IN MM UNLESS SPECIFIED OTHERWISE.
 3. ONLY WRITTEN DIMENSIONS ARE TO BE FOLLOWED, NO DIMENSIONS ARE TO BE PHYSICALLY MEASURED FROM THE DRAWING. DRAWINGS ARE NOT TO BE SCALED.
 4. CONTRACTORS / VENDORS MUST VERIFY DIMENSIONS ON THE PROJECT AND REPORT DISCREPANCIES IF ANY TO DESIGN TECHNICS.
 5. DRAWINGS SHALL BE READ IN CONJUNCTION WITH SERVICES / STRUCTURE RELATED DRAWINGS.

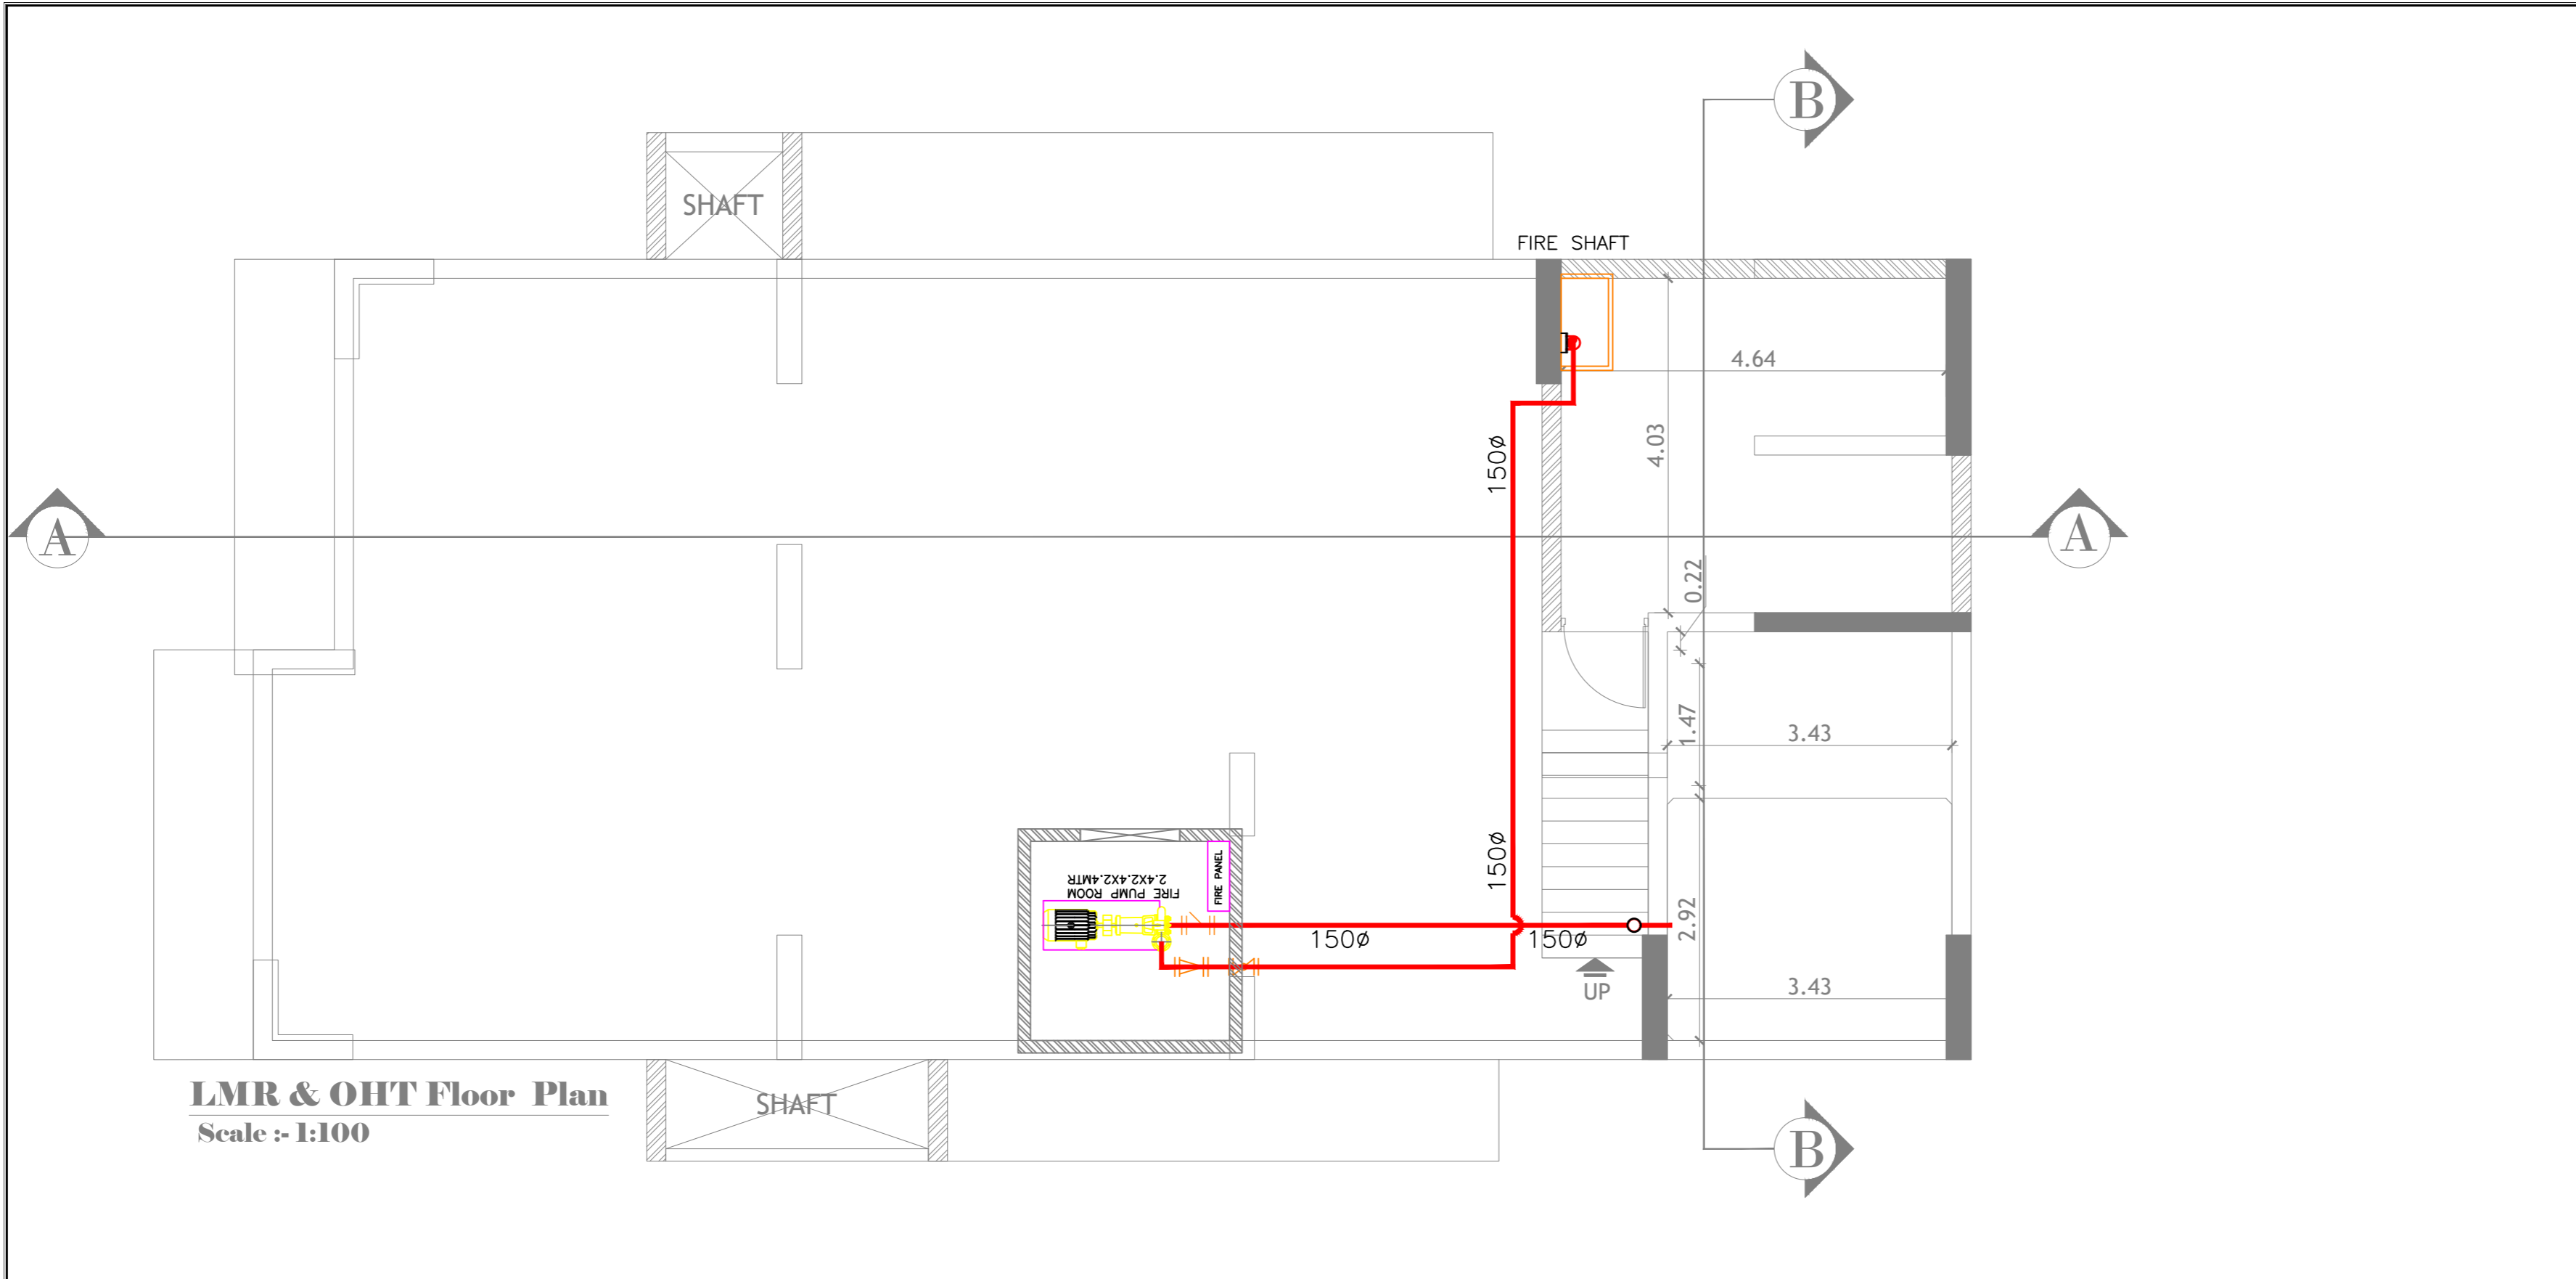

LMR & OHT Floor Plan
 Scale :- 1:100

REVISIONS:

REV. NO	DESCRIPTION	DATE	REMARK
R0	ISSUED FOR APPROVAL	05.07.2022	

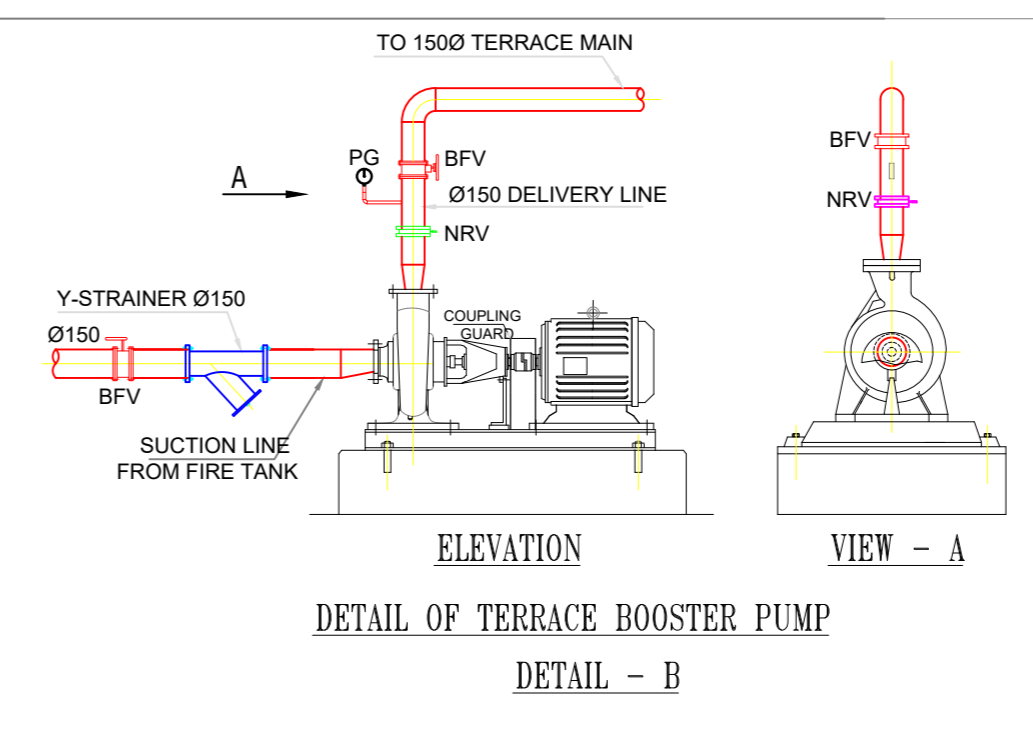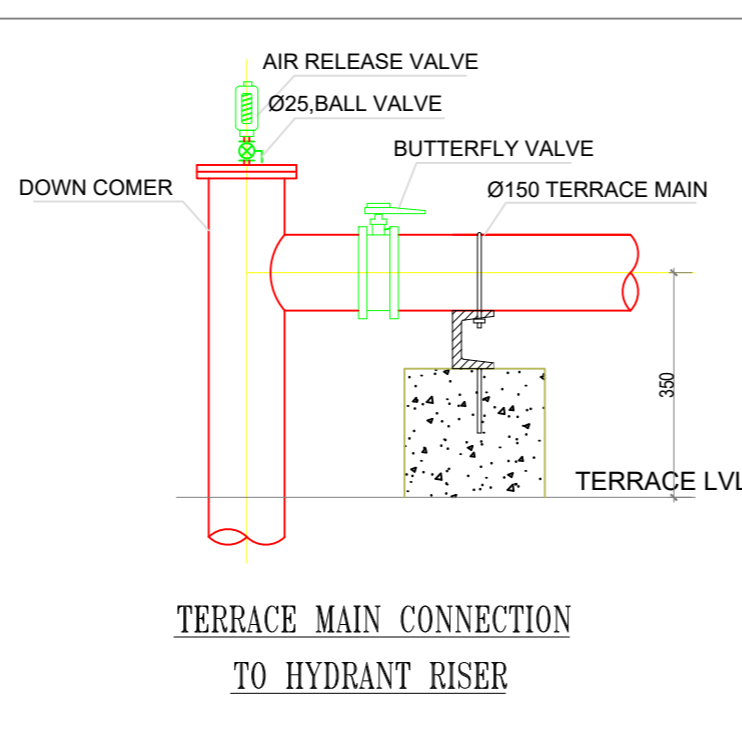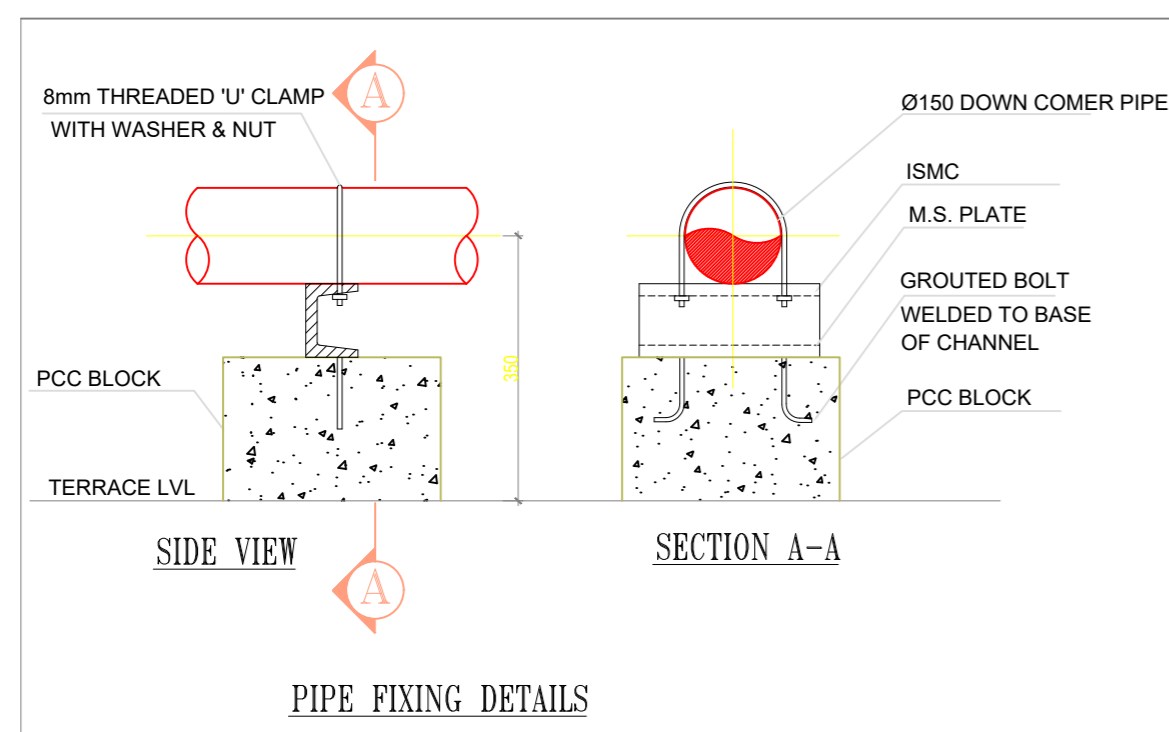

CLIENT:

ARCHITECT:
SHETGIRI & ASSOCIATES
 ARCHITECTS, ENGINEERS, INTERIOR DESIGNERS,
 PROJECT MANAGEMENT CONSULTANTS, VALUERS
 14-5 Power Block, 1st, 2nd, 3rd, 4th, 5th, 6th, 7th, 8th, 9th, 10th, 11th, 12th, 13th, 14th, 15th, 16th, 17th, 18th, 19th, 20th, 21st, 22nd, 23rd, 24th, 25th, 26th, 27th, 28th, 29th, 30th, 31st, 32nd, 33rd, 34th, 35th, 36th, 37th, 38th, 39th, 40th, 41st, 42nd, 43rd, 44th, 45th, 46th, 47th, 48th, 49th, 50th, 51st, 52nd, 53rd, 54th, 55th, 56th, 57th, 58th, 59th, 60th, 61st, 62nd, 63rd, 64th, 65th, 66th, 67th, 68th, 69th, 70th, 71st, 72nd, 73rd, 74th, 75th, 76th, 77th, 78th, 79th, 80th, 81st, 82nd, 83rd, 84th, 85th, 86th, 87th, 88th, 89th, 90th, 91st, 92nd, 93rd, 94th, 95th, 96th, 97th, 98th, 99th, 100th

MEP CONSULTANTS:
DESIGN TECHNICS
 11B, 11th Industrial Estate, 5th, 6th, 7th, 8th, 9th, 10th, 11th, 12th, 13th, 14th, 15th, 16th, 17th, 18th, 19th, 20th, 21st, 22nd, 23rd, 24th, 25th, 26th, 27th, 28th, 29th, 30th, 31st, 32nd, 33rd, 34th, 35th, 36th, 37th, 38th, 39th, 40th, 41st, 42nd, 43rd, 44th, 45th, 46th, 47th, 48th, 49th, 50th, 51st, 52nd, 53rd, 54th, 55th, 56th, 57th, 58th, 59th, 60th, 61st, 62nd, 63rd, 64th, 65th, 66th, 67th, 68th, 69th, 70th, 71st, 72nd, 73rd, 74th, 75th, 76th, 77th, 78th, 79th, 80th, 81st, 82nd, 83rd, 84th, 85th, 86th, 87th, 88th, 89th, 90th, 91st, 92nd, 93rd, 94th, 95th, 96th, 97th, 98th, 99th, 100th

PROJECT:
 SBI STAFF QUARTER

DRAWING NAME:
 TERRACE FLOOR FIRE FIGHTING LAYOUT

DRAWING NO:
 DT-SBI/FF/010

SCALE:	DATE:	REVISION:	SHEET SIZE:
NTS	05.07.2022	R0	A0
DRAWN BY:	CHECKED BY:	APPROVED BY:	NORTH
TAMIL	PJ	AS	