

GROUND FLOOR



CLIENT :  
**SBI**  
 STATE BANK OF INDIA

PROJECT :  
**PROPOSED INTERIOR LAYOUT OF INSPECTION AND AUDIT DEPARTMENT AT GACHIBOWLI HYDERABAD**

DRAWING TITLE :  
**GROUND FLOOR INTERIOR LAYOUT**

REV NO.	DATE	DESCRIPTION
1	23-09-23	
2		
3		
4		
5		
6		

job number:  
**2022 / 108**

drawing number  
**ABH/SBI/IAU / LAYOUT / 01**

SHEET NO: **01 / 02**


initials	signed by	date
	BHANU	19-09-23
	E.SREENATH	

scale: **NTS**

CAD file



This drawing is copyright and may not be copied or reproduced in any form w/out prior consent in writing of ABHIKRAM architects hyd

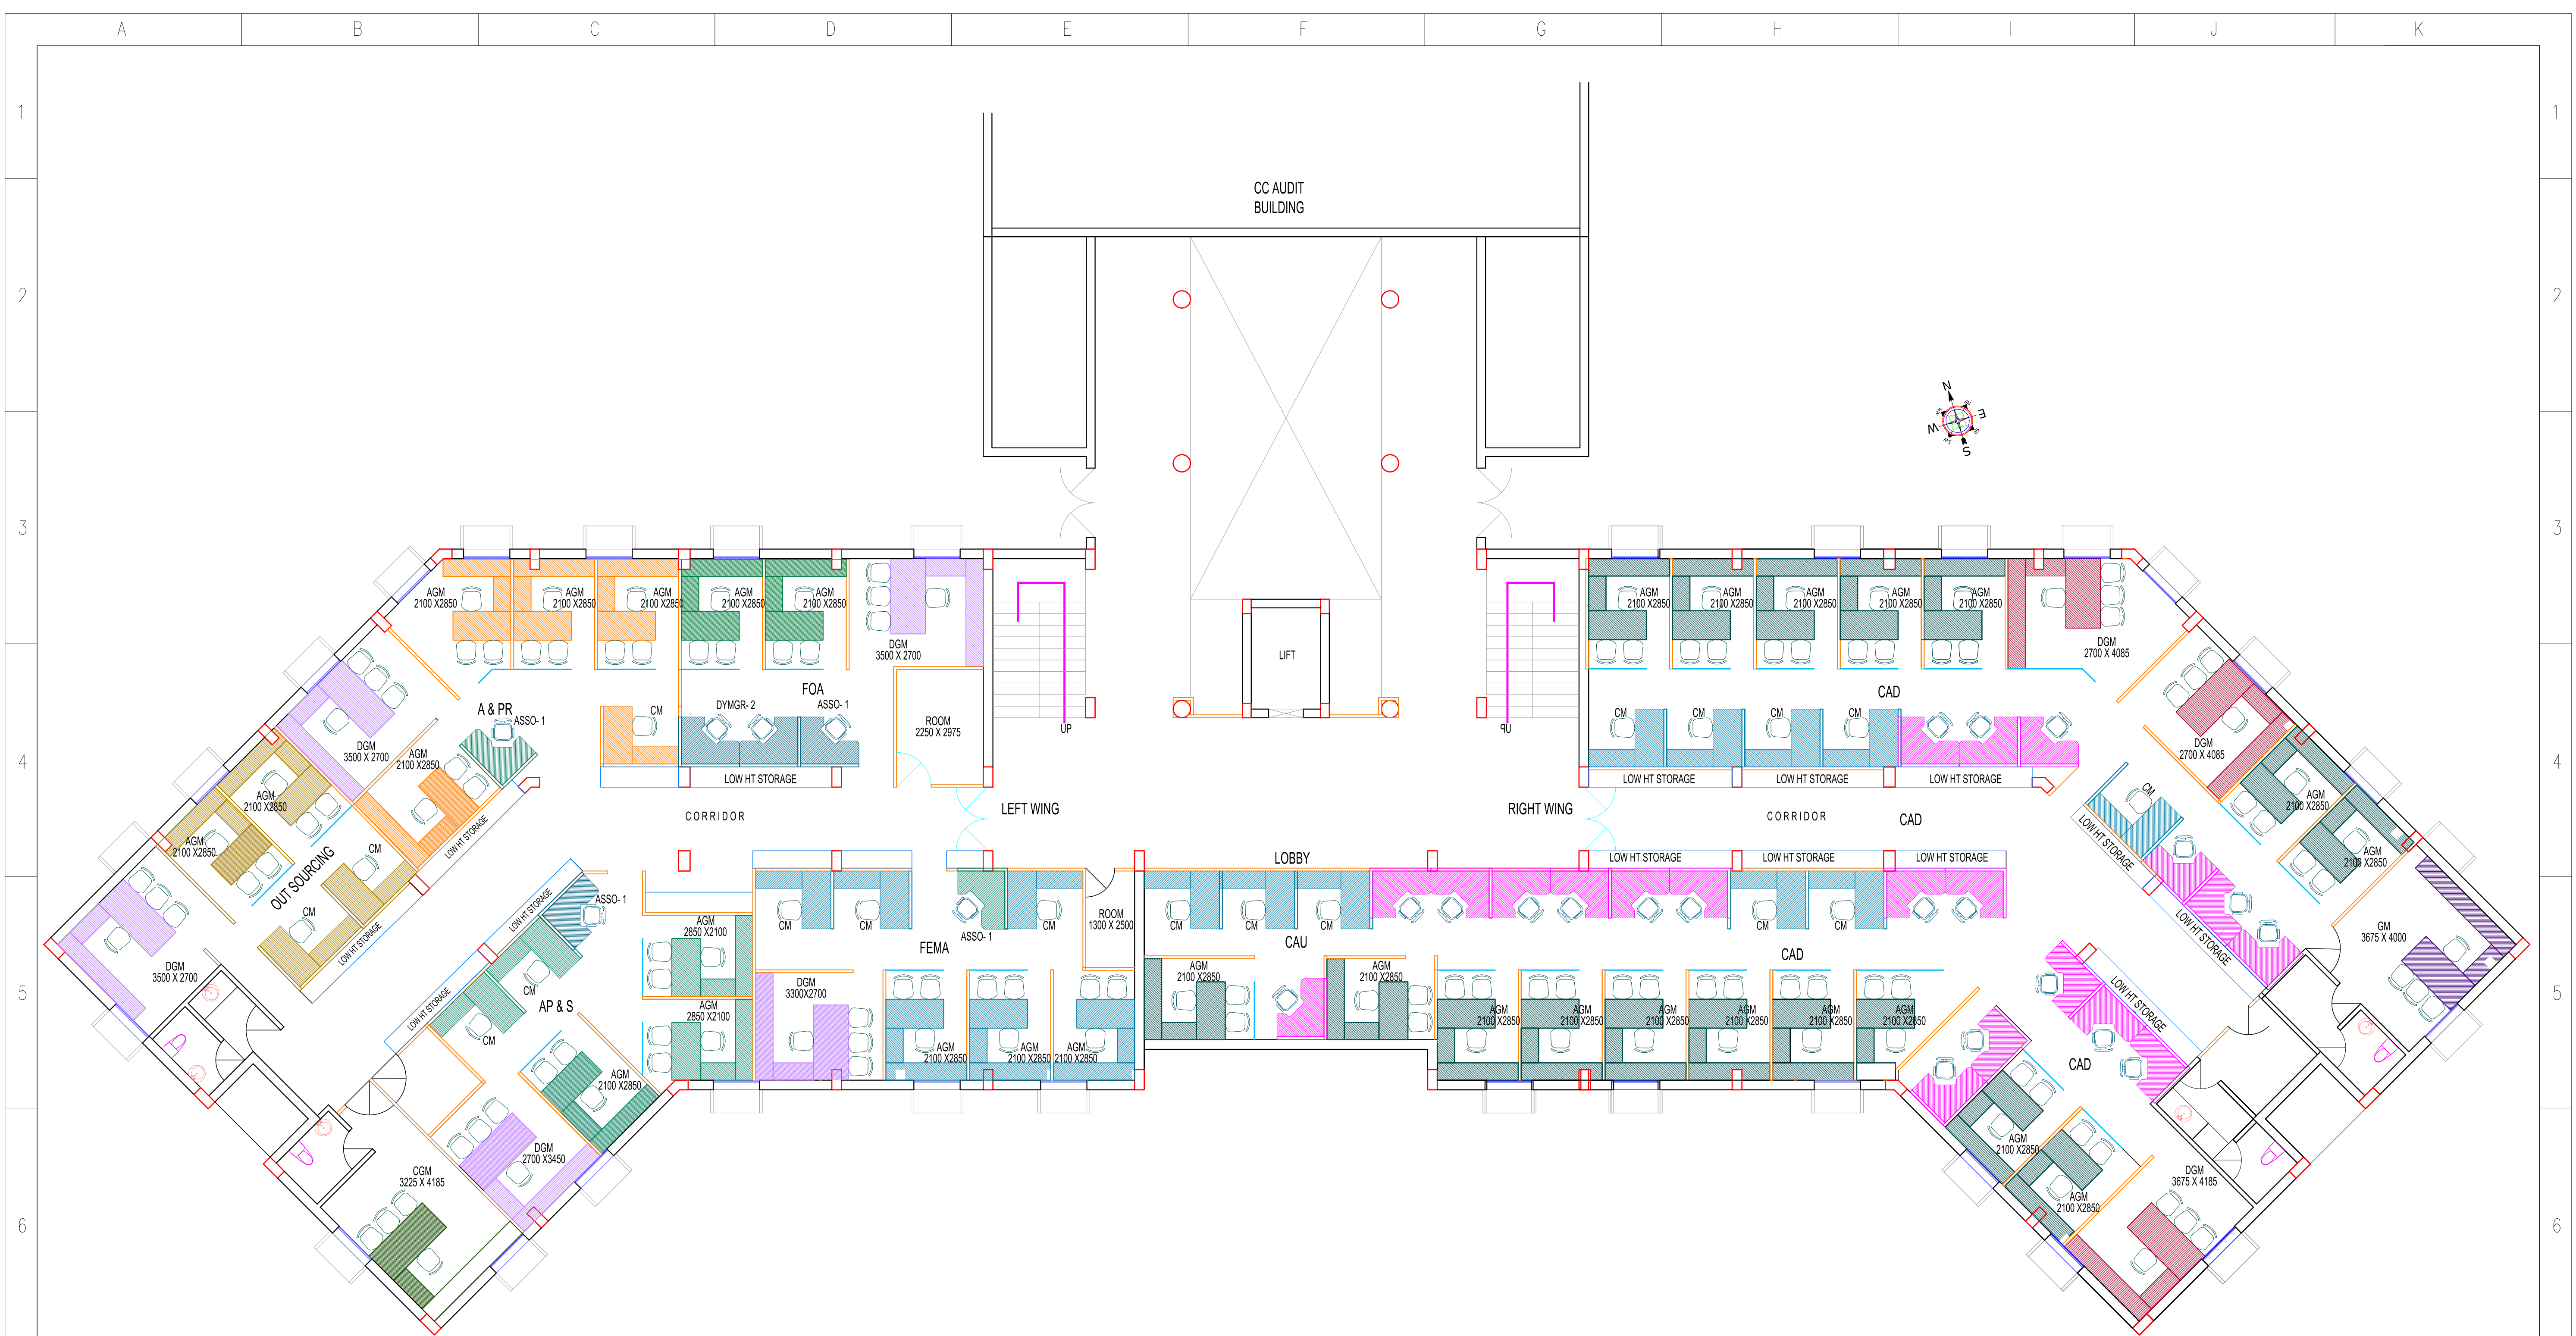

SECOND FLOOR



CLIENT :  
**SBI**  
 STATE BANK OF INDIA

PROJECT :  
**PROPOSED INTERIOR LAYOUT OF INSPECTION AND AUDIT DEPARTMENT AT GACHIBOWLI HYDERABAD**

DRAWING TITLE :  
**SECOND FLOOR INTERIOR LAYOUT**

REV NO.	DATE	DESCRIPTION
1	23-09-23	
2		
3		
4		
5		
6		

job number:  
**2022 / 108**

drawing number  
**ABHI/SBI/IAU / LAYOUT / 01**

SHEET NO: **02 / 02**

initials	signed by	date
BHANU		19-09-23
E.SREENATH		

drawn by  
 designed & checked by  
 approved by


scale  
 NTS

CAD file

CONSULTANTS :

**abhikram-s**  
 Architects, Interiors Designers, Valuers,  
 Urban Planners, Project Managers

This drawing is copyright and may not be copied or reproduced in any form w/out prior consent in writing of ABHIKRAM architects hyd

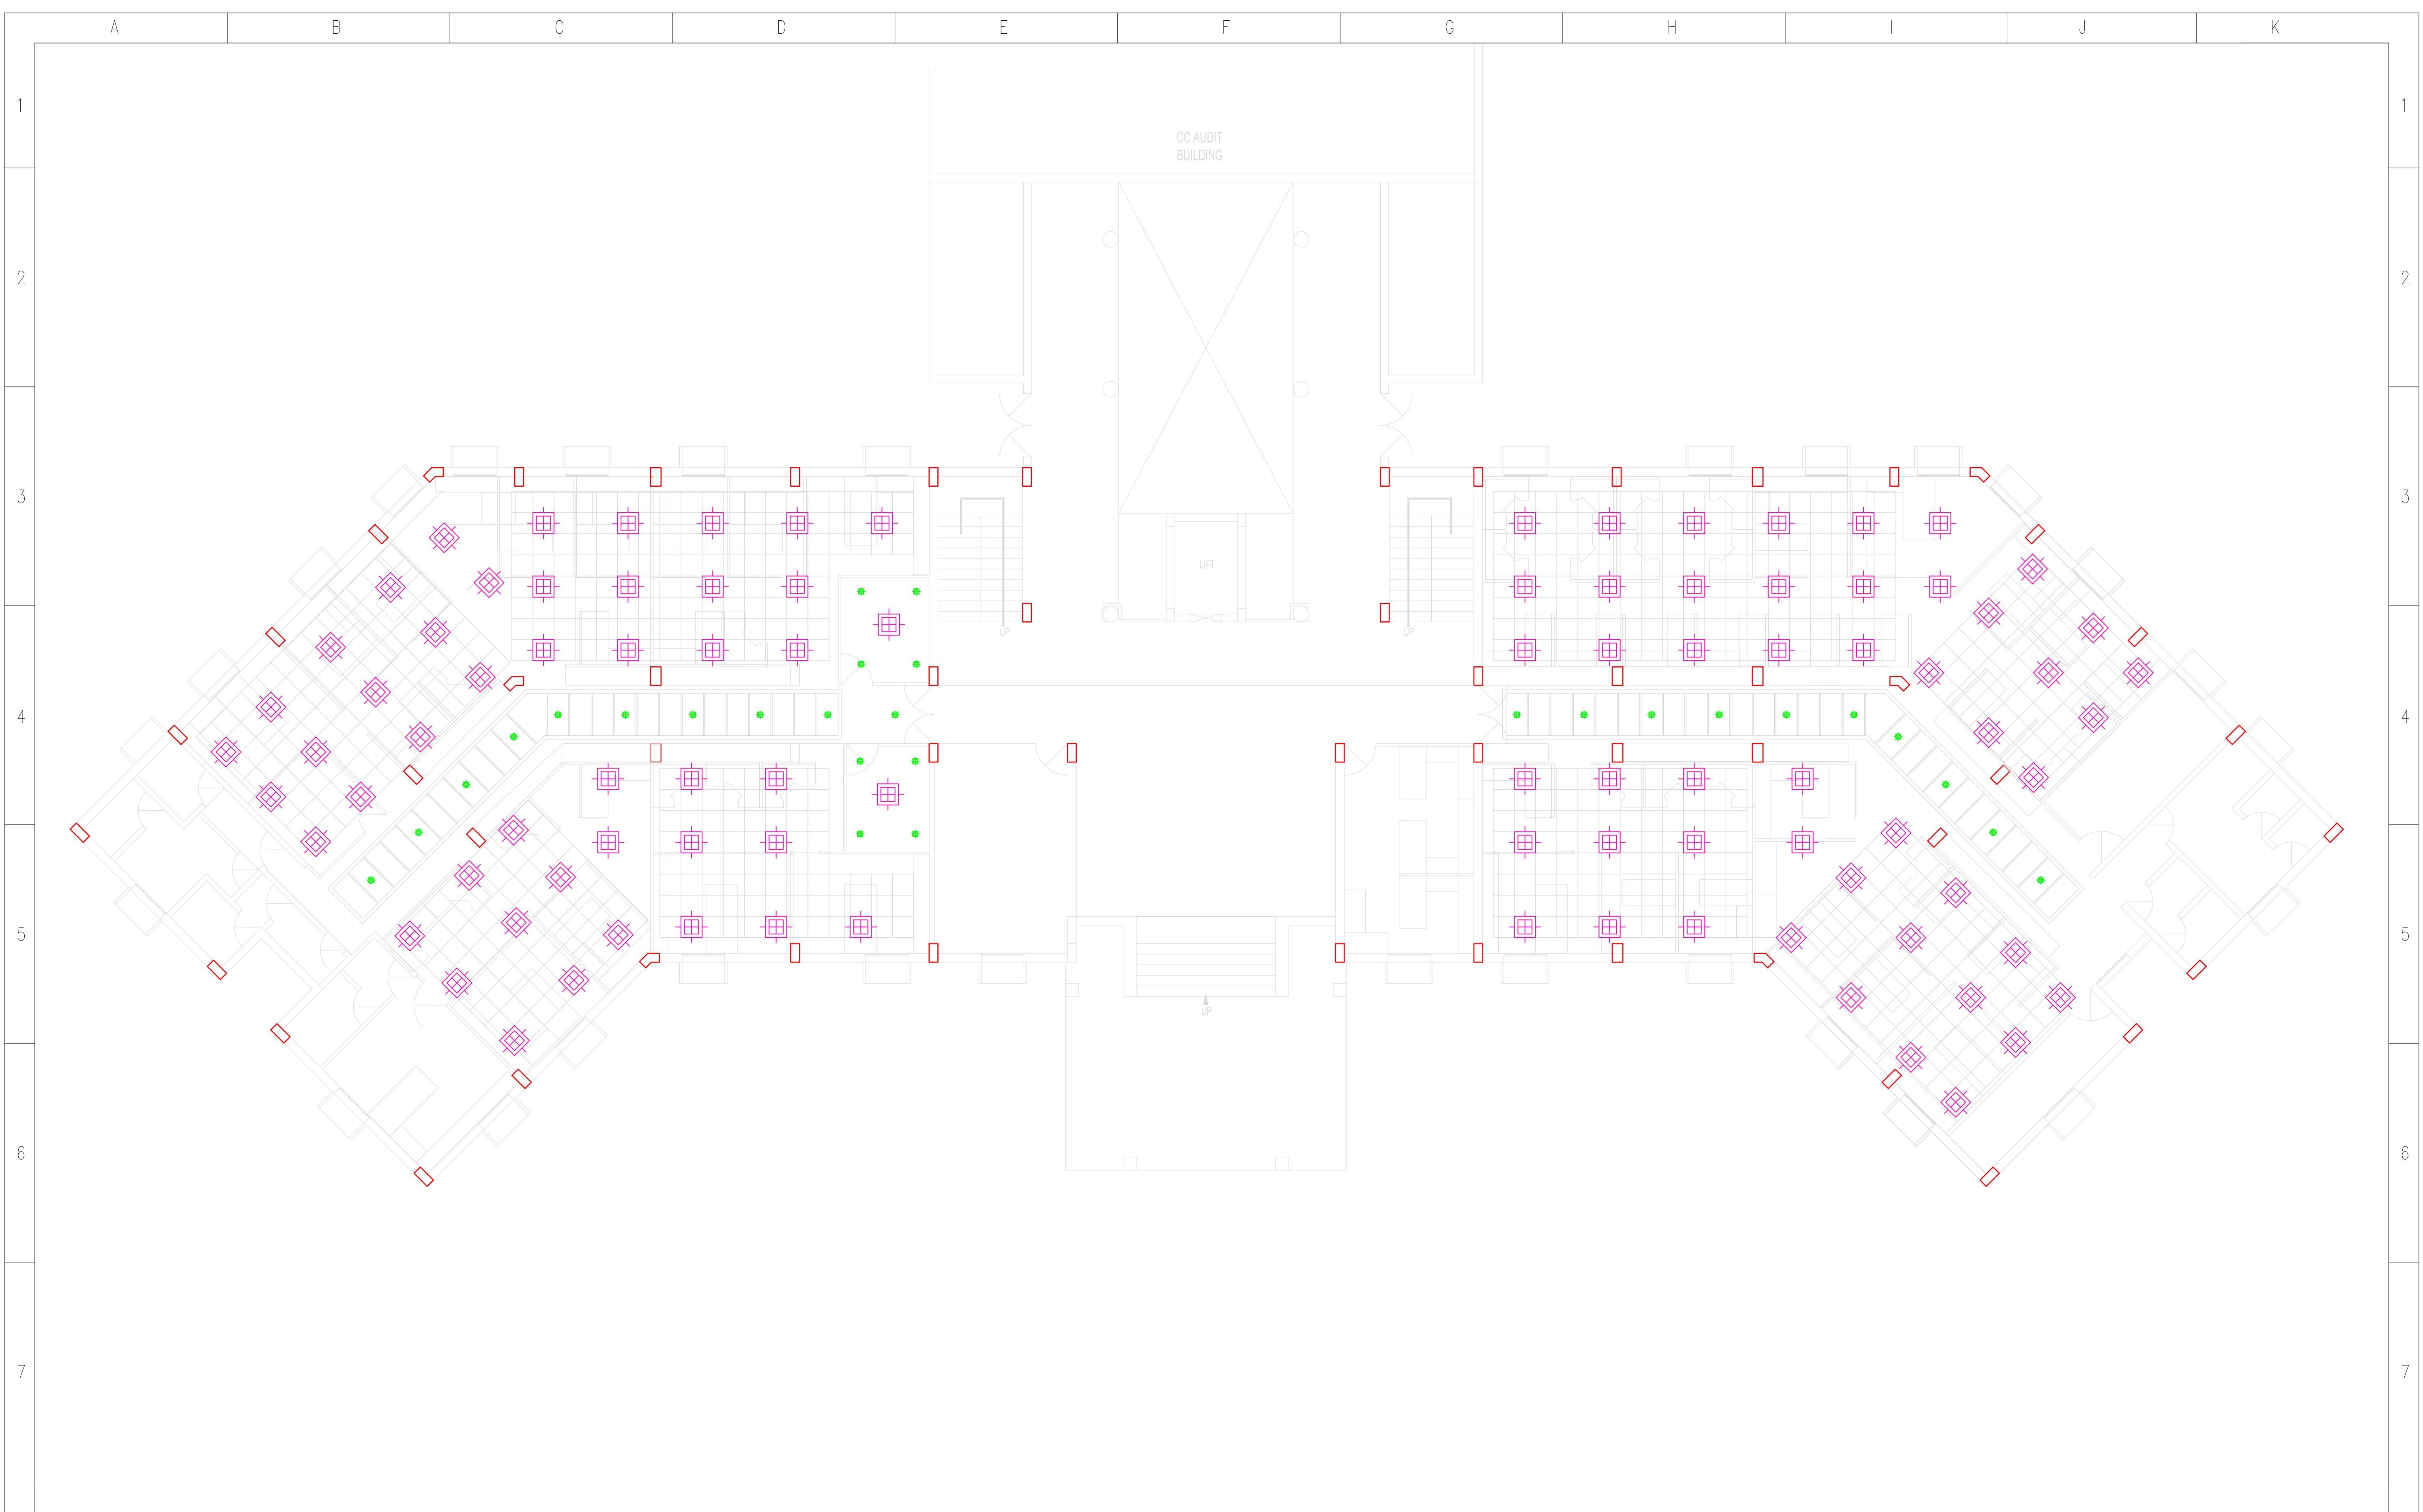

CLIENT :  
**STATE BANK OF INDIA**

PROJECT :  
**PROPOSED RENOVATION OF INSPECTION AND  
 AUDIT DEPARTMENT AT GACHIBOWLI, HYDERABAD**

DRAWING TITLE :  
**GROUND FLOOR ELECTRICAL LAYOUT**

REV NO.	DATE	DESCRIPTION
1	23-09-23	
2		
3		
4		
5		
6		


job number: <b>2022 / 108</b>	drawn by BHANU	initials BHANU	signed by E.SREENATH	date 08-01-24
drawing number <b>ABHI/SBI/I&amp;AU / ELE / 01</b>	designed & checked by approved by			
SHEET NO: <b>01 / 02</b>	scale NTS	CAD file		

CONSULTANTS :



**abhikram-s**  
 Architects, Interiors Designers, Valuers,  
 Urban Planners, Project Managers

This drawing is copyright and may not be copied or reproduced in any form w/out prior consent in writing of ABHIKRAM architects hyd

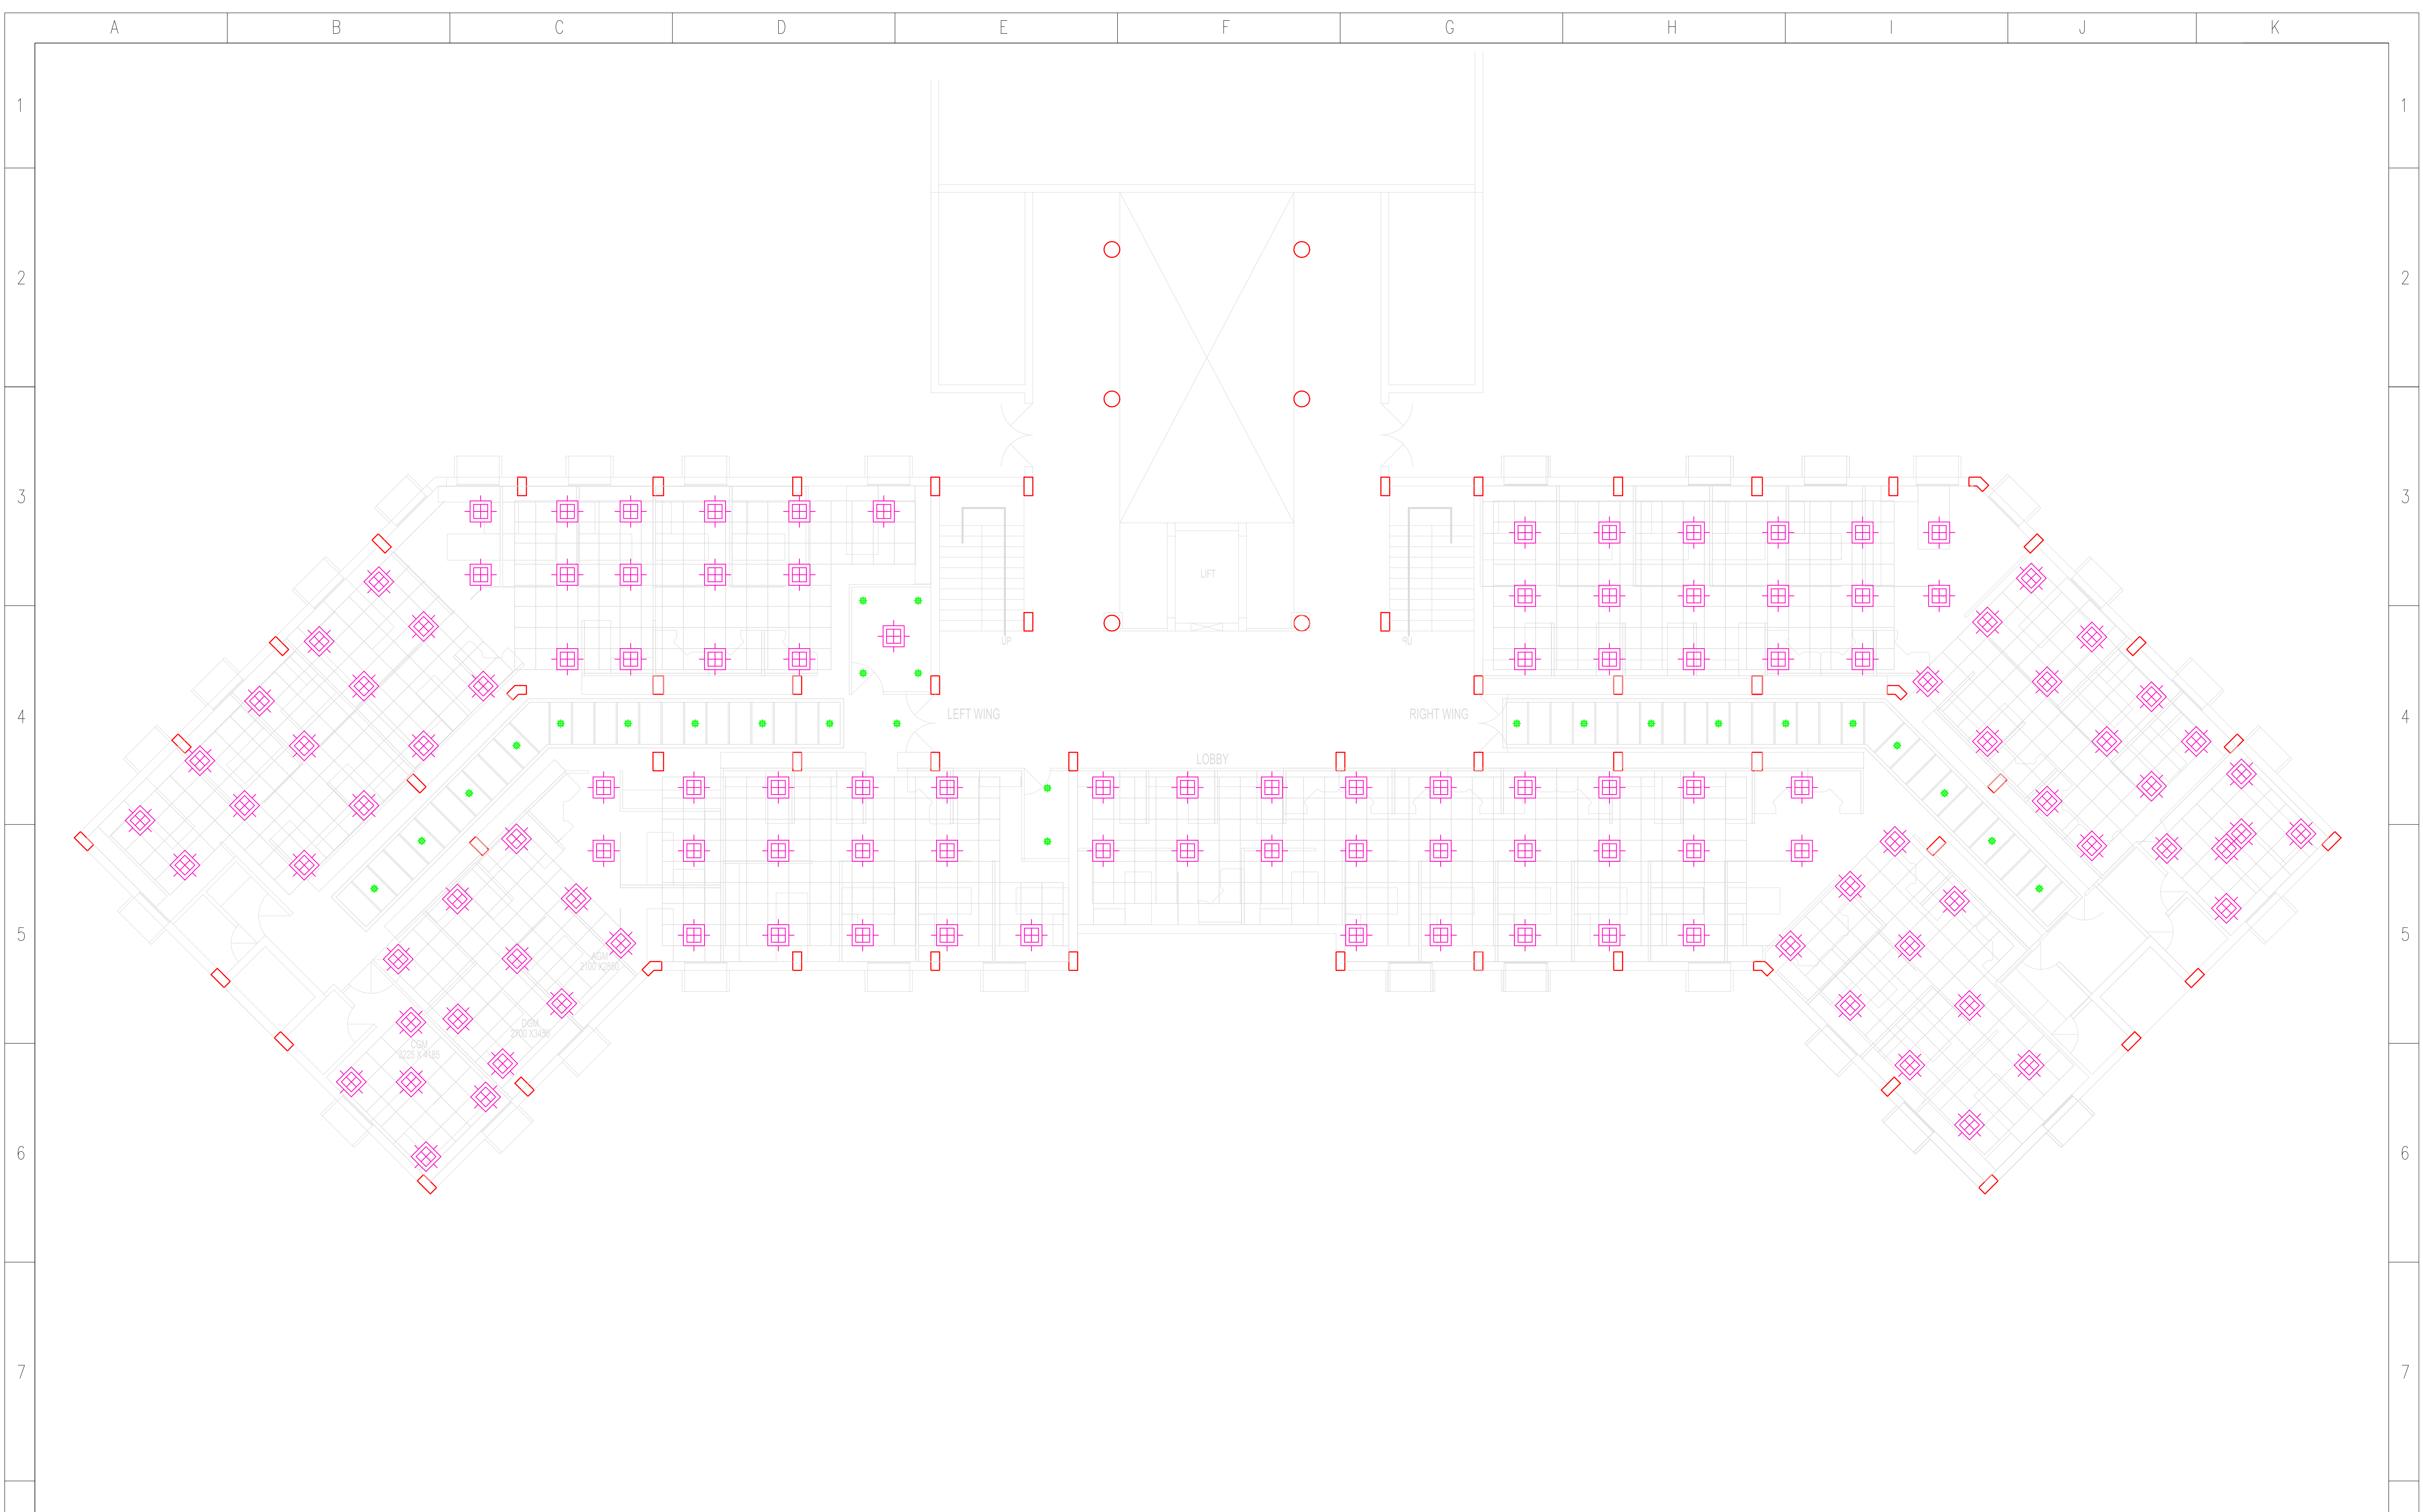

CLIENT :  
**STATE BANK OF INDIA**

PROJECT :  
**PROPOSED RENOVATION OF INSPECTION AND  
 AUDIT DEPARTMENT AT GACHIBOWLI, HYDERABAD**

DRAWING TITLE :  
**SECOND FLOOR ELECTRICAL LAYOUT**

REV NO.	DATE	DESCRIPTION
1	23-09-23	
2		
3		
4		
5		
6		

job number:  
**2022 / 108**

drawing number  
**ABHI/SBI/I&AU /  
 ELE / 02**

SHEET NO: **02 / 02**

drawn by	BHANU	signed by		date	08-01-24
designed & checked by	E.SREENATH	approved by			
scale	NTS			CAD file	

CONSULTANTS :

**abhikram-s**  
 Architects, Interiors Designers, Valuers,  
 Urban Planners, Project Managers

This drawing is copyright and may not be copied or reproduced in any form w/out prior consent in writing of ABHIKRAM architects hyd