


TENDER DRAWING

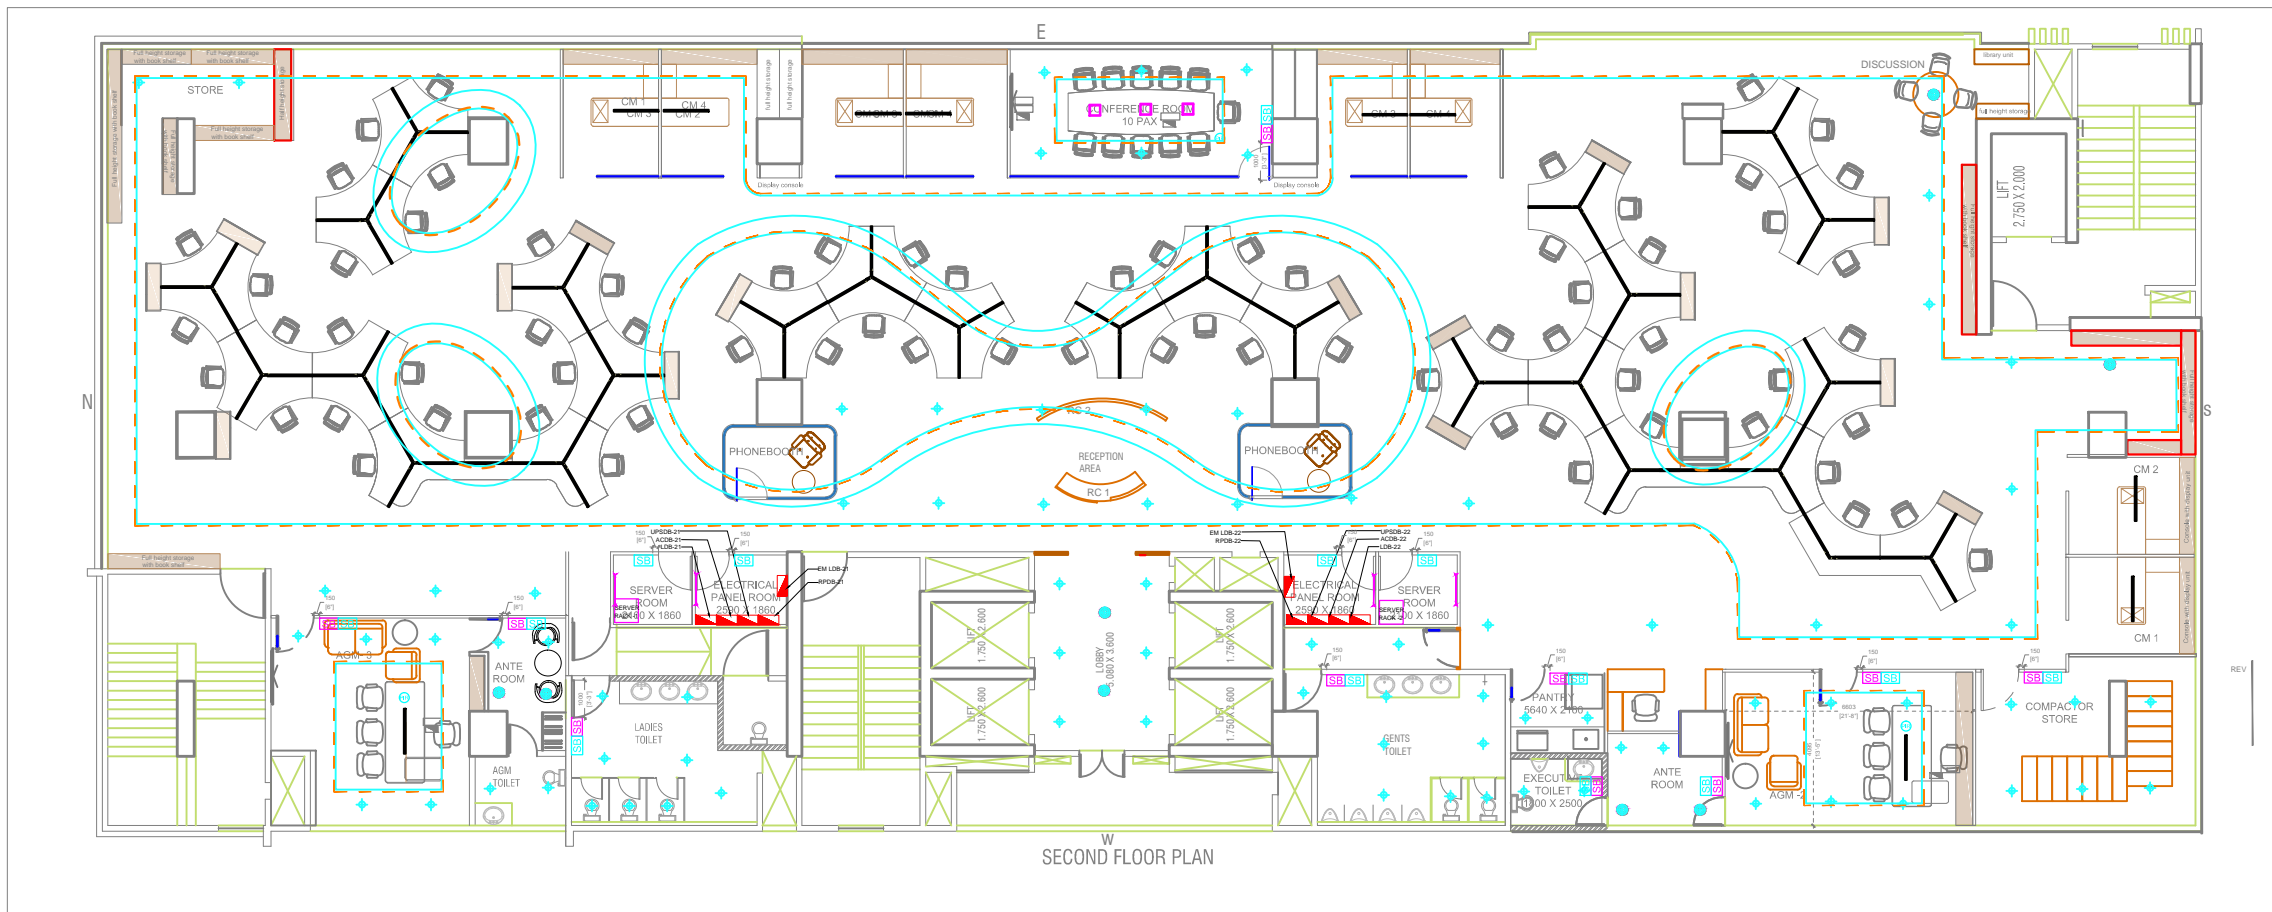

SECOND FLOOR PLAN

LEGEND FOR LED LIGHTS

NO.	SYMBOL	DESCRIPTION	QTY	IMAGE
1	—	15W SUSPENDED LUMINAIRE CAT NO. WPRO-LM43-31(DALI) 140 LGWC		
2	—	15W SUSPENDED LUMINAIRE CAT NO. WPRO-LM43-32(DALI) 140 LGWC		
3	◆	12W DOWNLIGHTER (CAT NO. WPRO-L26-181 (40W/40))		
4	◆	15W RECESSED 2x2 LUMINAIRE (CAT NO. WPRO- LM30R-42-L-D40-V8)		
5	◆	15W RECESSED MOUNTED LED LUMINAIRE (CAT NO. WPRO- LM30R-42-L-D40-V8)		
6	◆	15W RECESSED LED 2x2 LUMINAIRE (CAT NO. WPRO-LM30R-42-L-D40-V8)		
7	◆	PIR SHAPE ANTI-CORON- ANGULAR SUSPENDED LUMINAIRE (CAT NO. WPRO-LM4-L1-L26-V6(W/02))		
8	◆	PIR ANGLE SUSPENDED LUMINAIRE (CAT NO. WPRO- LM34-20-40-40WC2)		
9	—	20W AFT TUBELIGHT LINEAR BATTEN		
10	—	LED STRIP - COVE LIGHTS		

LEGEND FOR ELECTRICAL

SB	SWITCH BOARD WITH 6A SOCKET
ESB	EM SWITCH BOARD
—	LIGHT CONTROL(NORMAL)
—	LIGHT CONTROL (EMERGENCY)
—	LIGHT CIRCUITING(NORMAL)
—	LIGHT CIRCUITING(EMERGENCY)
■	DISTRIBUTION BOARDS
○	PIR SENSOR

NOTE:
INCUBICLE SWITCHBOARDS NOT CONSIDERED,
AS IT WILL BE CONTROLLED FROM COMMON
SWITCHBOARDS/MCB.

R1	REVISED AS PER COMMENTS	MSP	SMJ	PSK	19.11.24
R-0	TENDER DRAWING	MSP	SMJ	PSK	13.11.24
REV	PARTICULARS OF REVISION	DRN	BYCHKD	BYAPRD	BY DATE

REVISIONS IN DRAWINGS

ARCHITECT :-
MITIMITRA ARCHITECT AND ASSOCIATES

PMC :-
-

CLIENT :-
SBI KHARADI

PROJECT :-
CLOCK TOWER, LHO, SBI, KHARADI, PUNE

TITLE :-
LIGHTING LAYOUT-SECOND FLOOR

SCALE	DATE	DRG NO.	REV.	ORIENTATOR
1:100	13.11.24	1658-EL-LTG-02	R-0	

RELEASED FOR PRELIMINARY TENDER INFORMATION APPROVAL CONSTRUCTION